
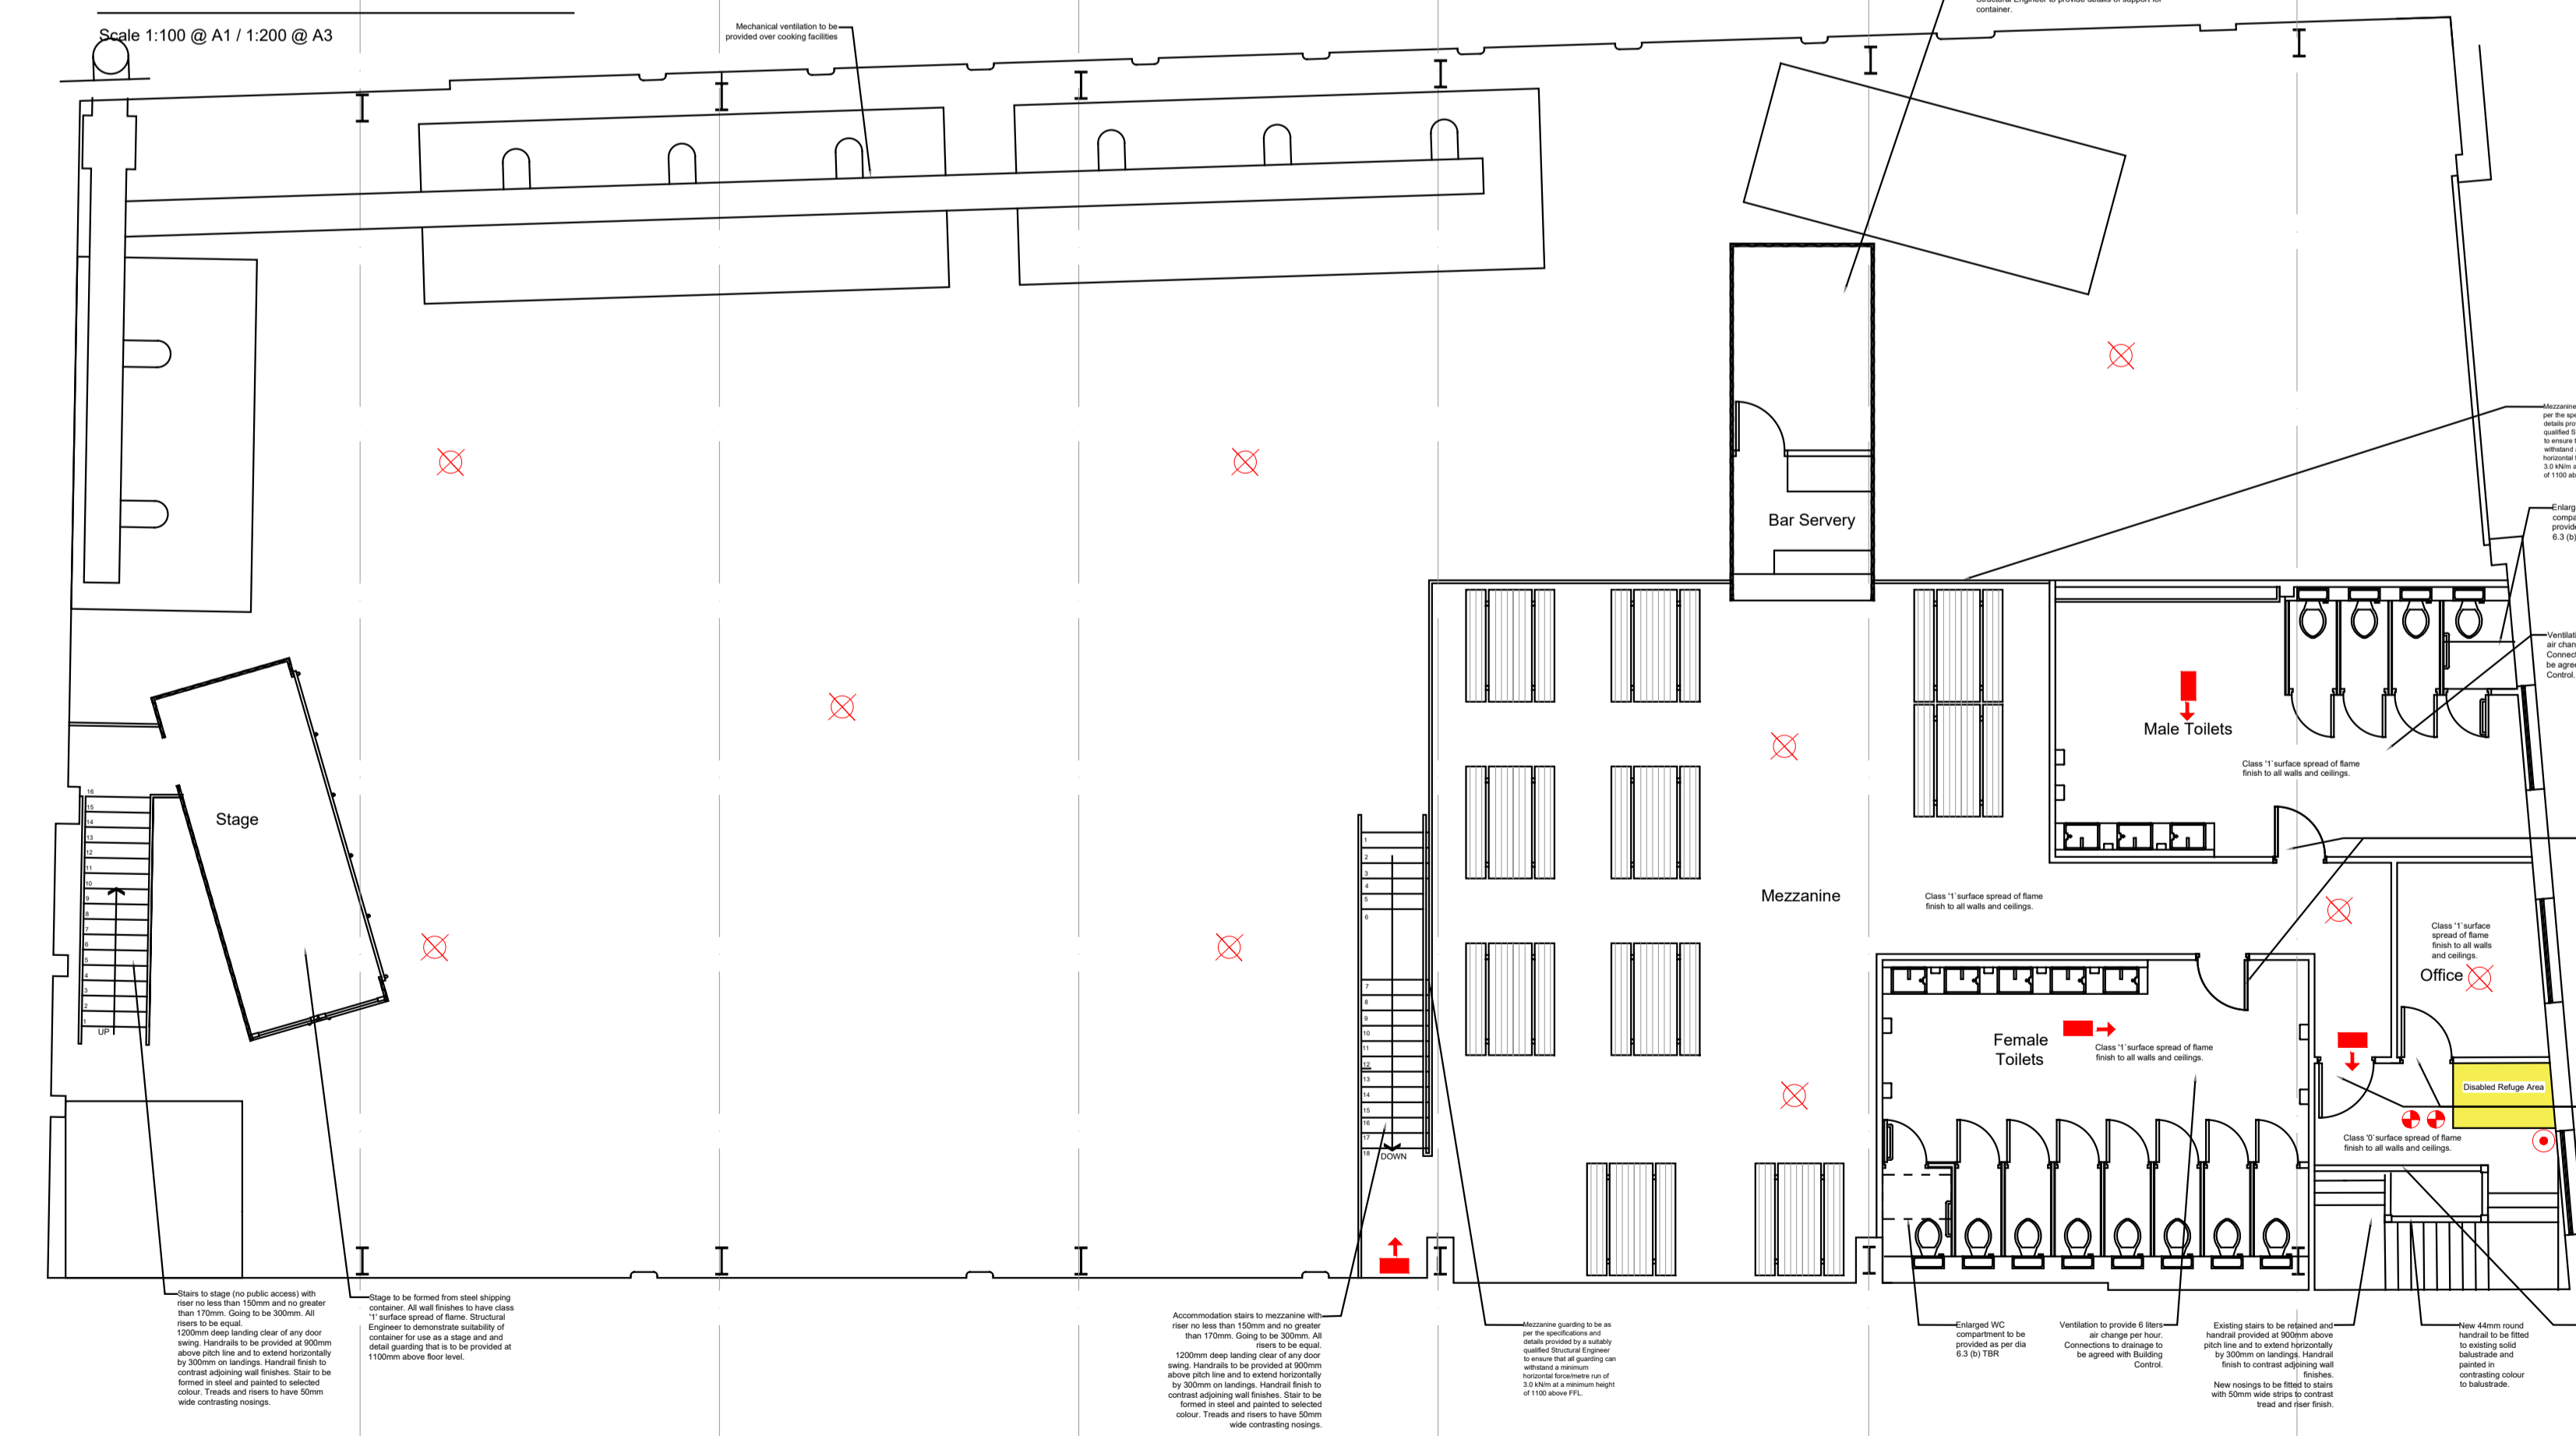



Proposed General Arrangement Plans

Scale 1:100 @ A1 / 1:200 @ A3

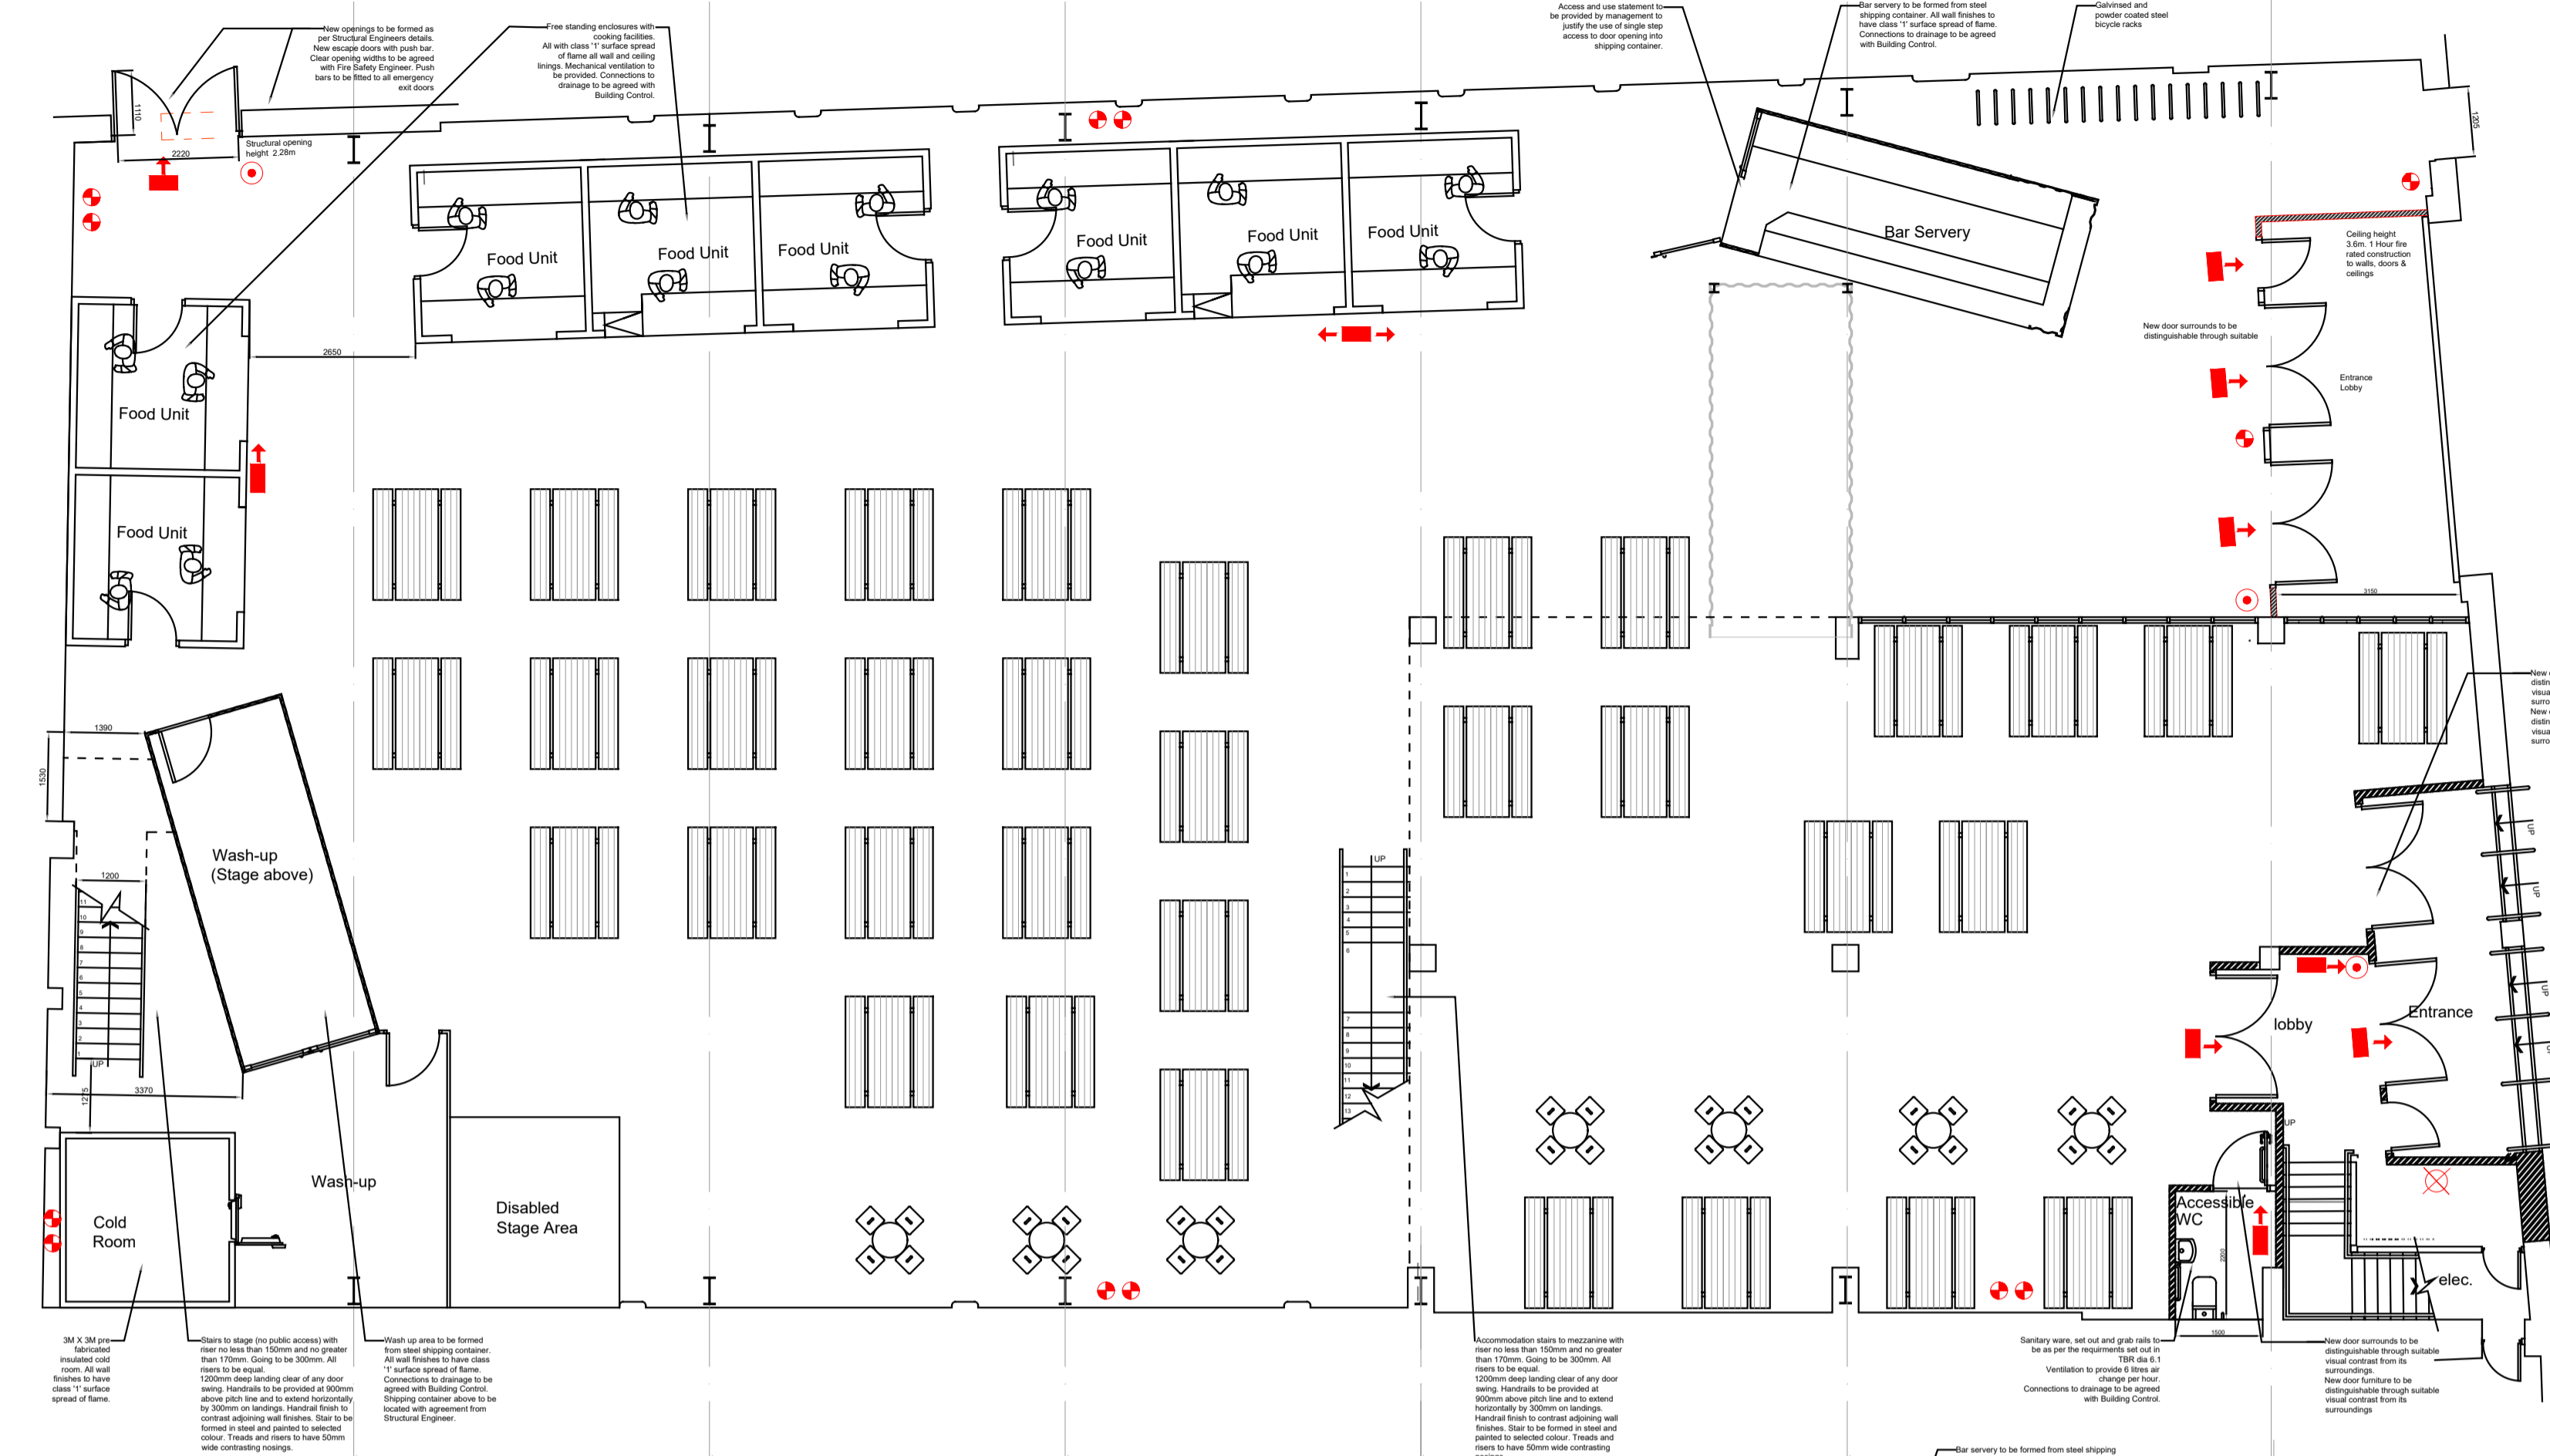

Proposed Mezzanine Floor GA Plan
Scale 1:100 @ A1 / 1:200 @ A3

Appendix 2

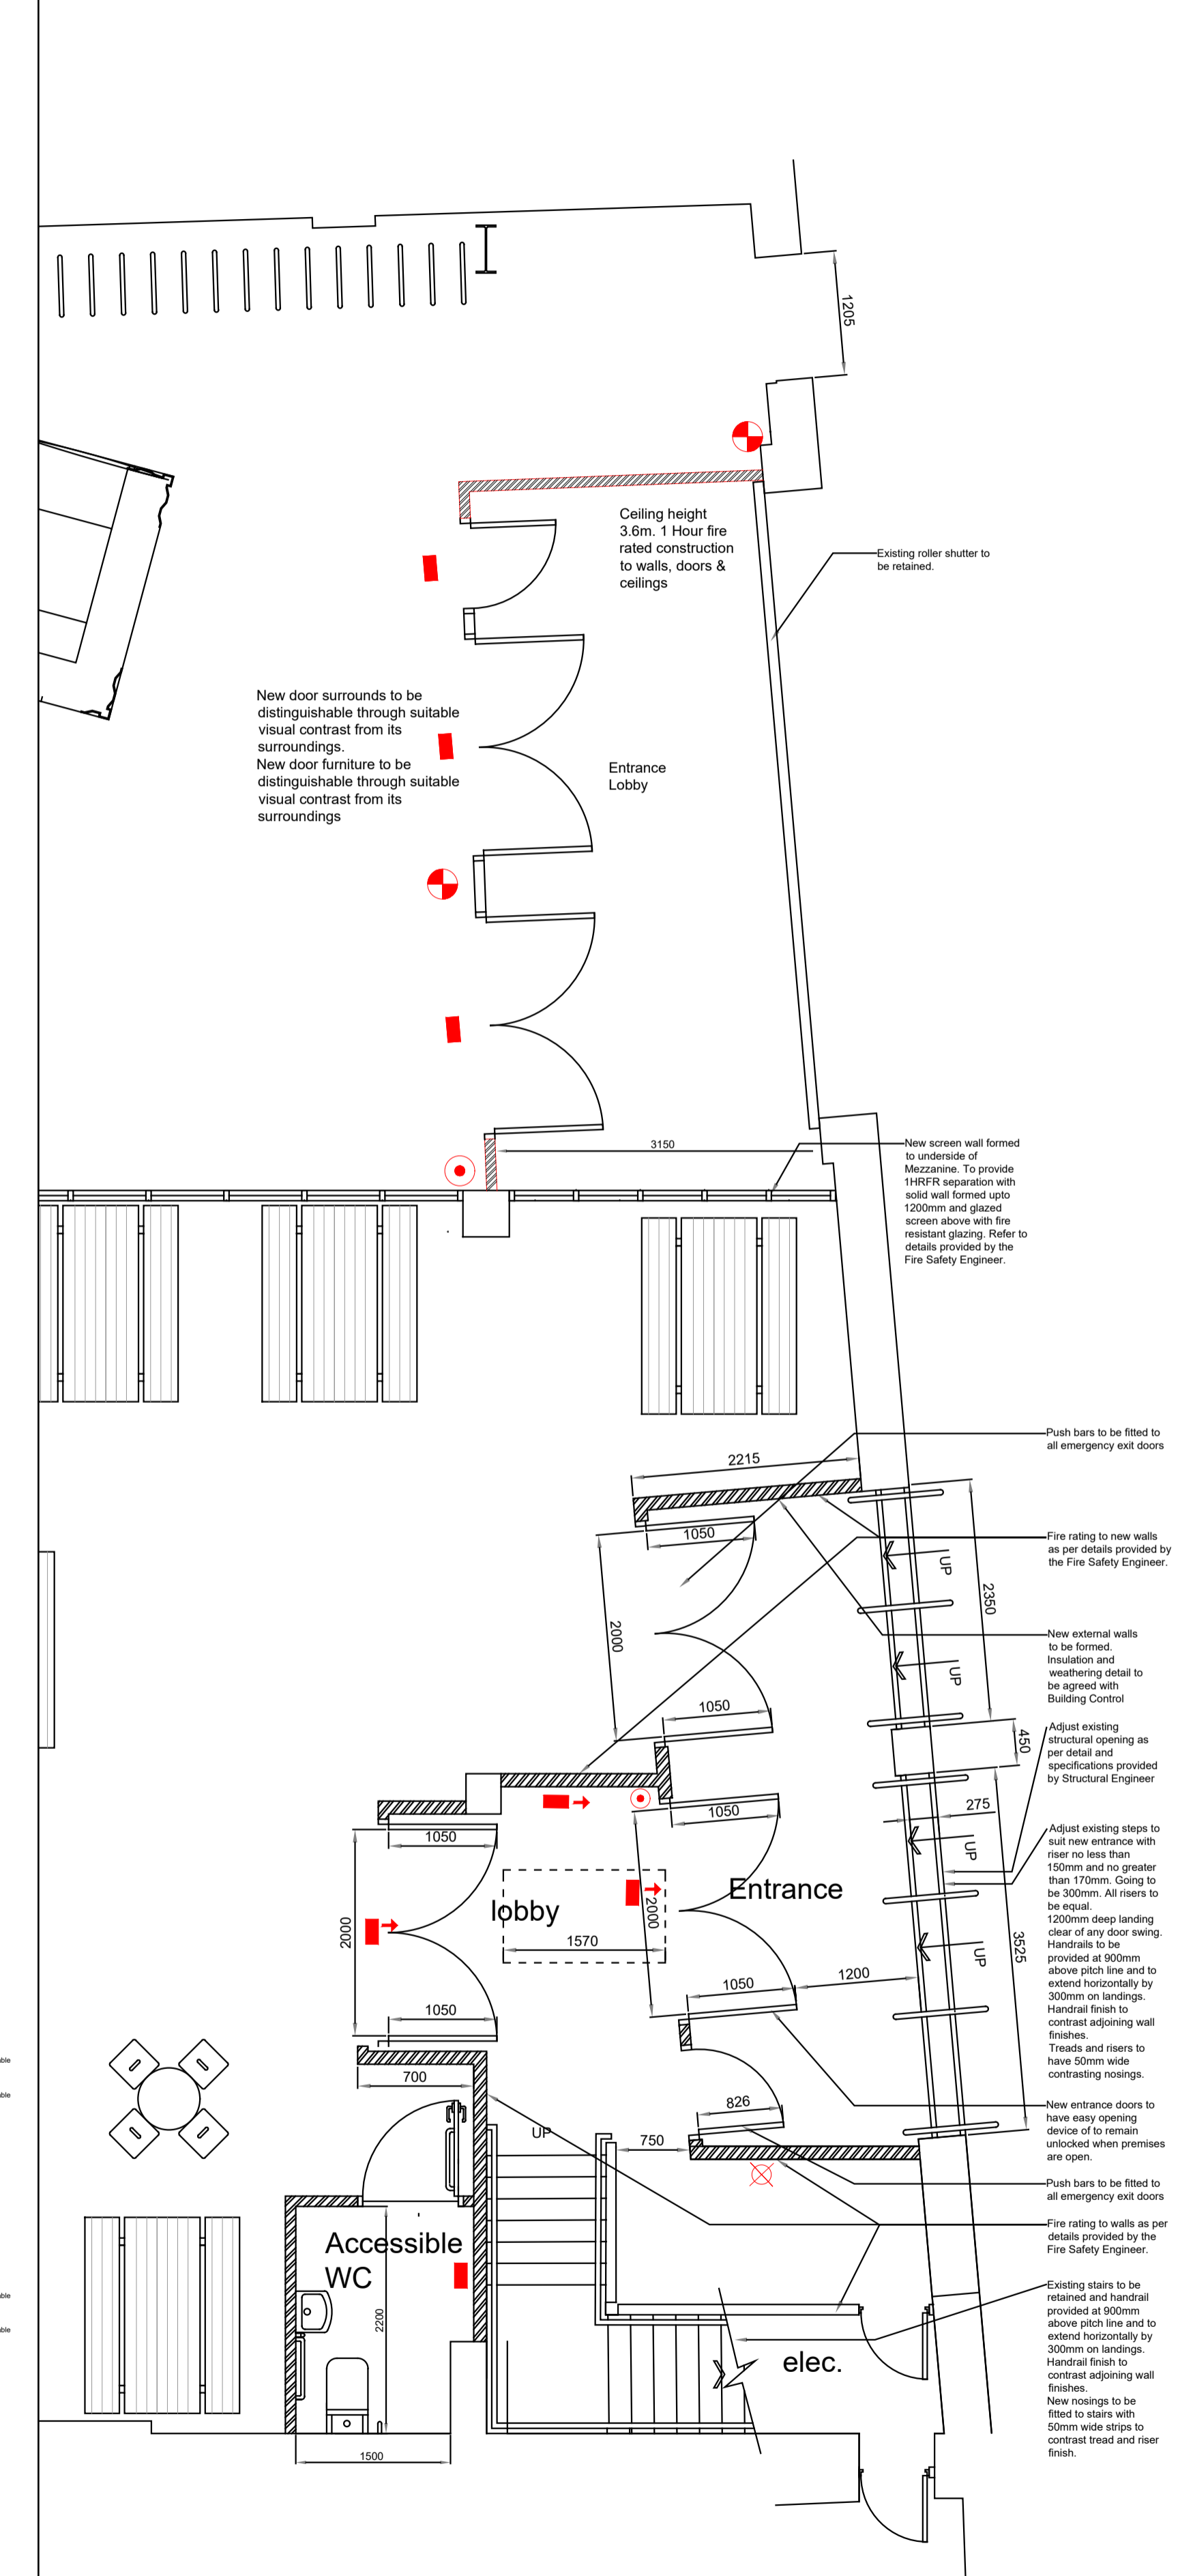

Proposed Ground Floor Entrance Detail Plan
Scale 1:50 @ A1 / 1:100 @ A3

- KEY :
- FIRE EXIT SIGN
 - BREAK POINT
 - EMERGENCY LIGHTING
 - SMOKE DETECTOR

PROJECT	Common Market		
ADDRESS	16 - 20 Dunbar Street, Belfast, BT1 2LH		
CLIENT	L Bannon		
DRG NO	REV	SCALE	DATE
PL-01	A	1:100@A1	Aug 22
DRAWN BY	CHECKED BY		
MS	HJ		
DRG TITLE	Proposed Floor Plans - Electrical / Fire		