



Proposed General Arrangement Plans

Scale 1:100 @ A1 / 1:200 @ A3

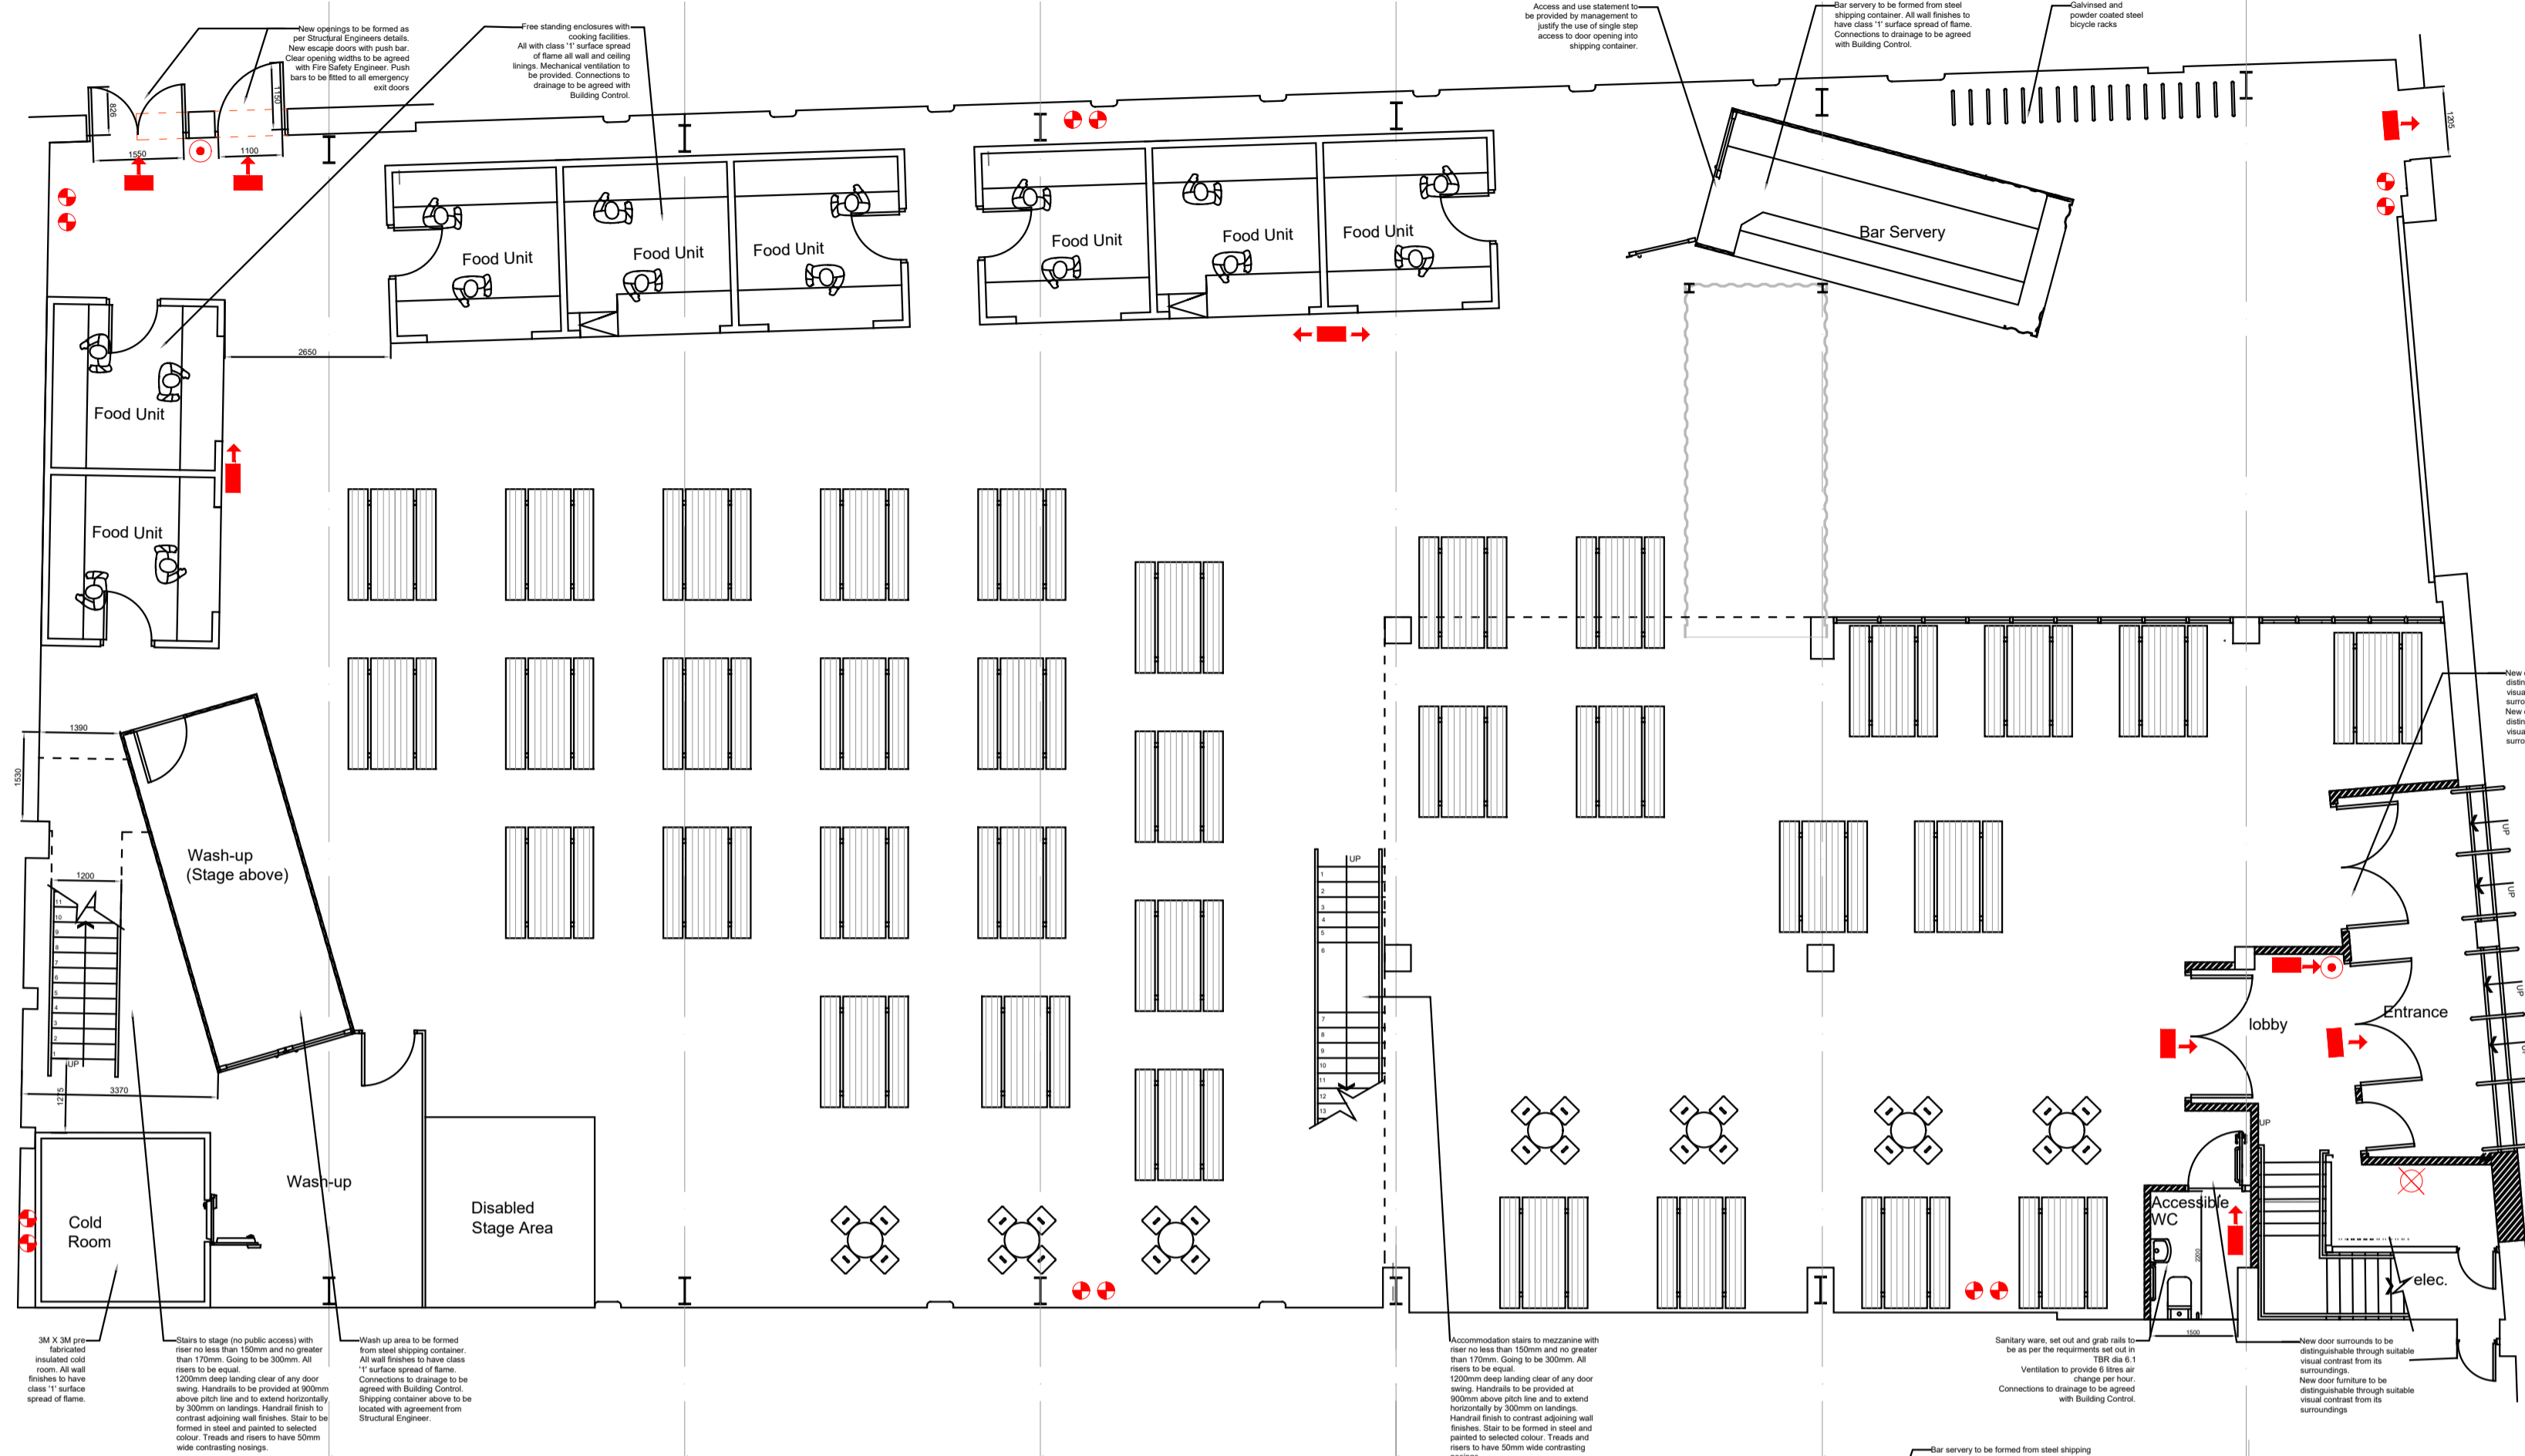


Scale 1:100 @ A1 / 1:200 @ A3

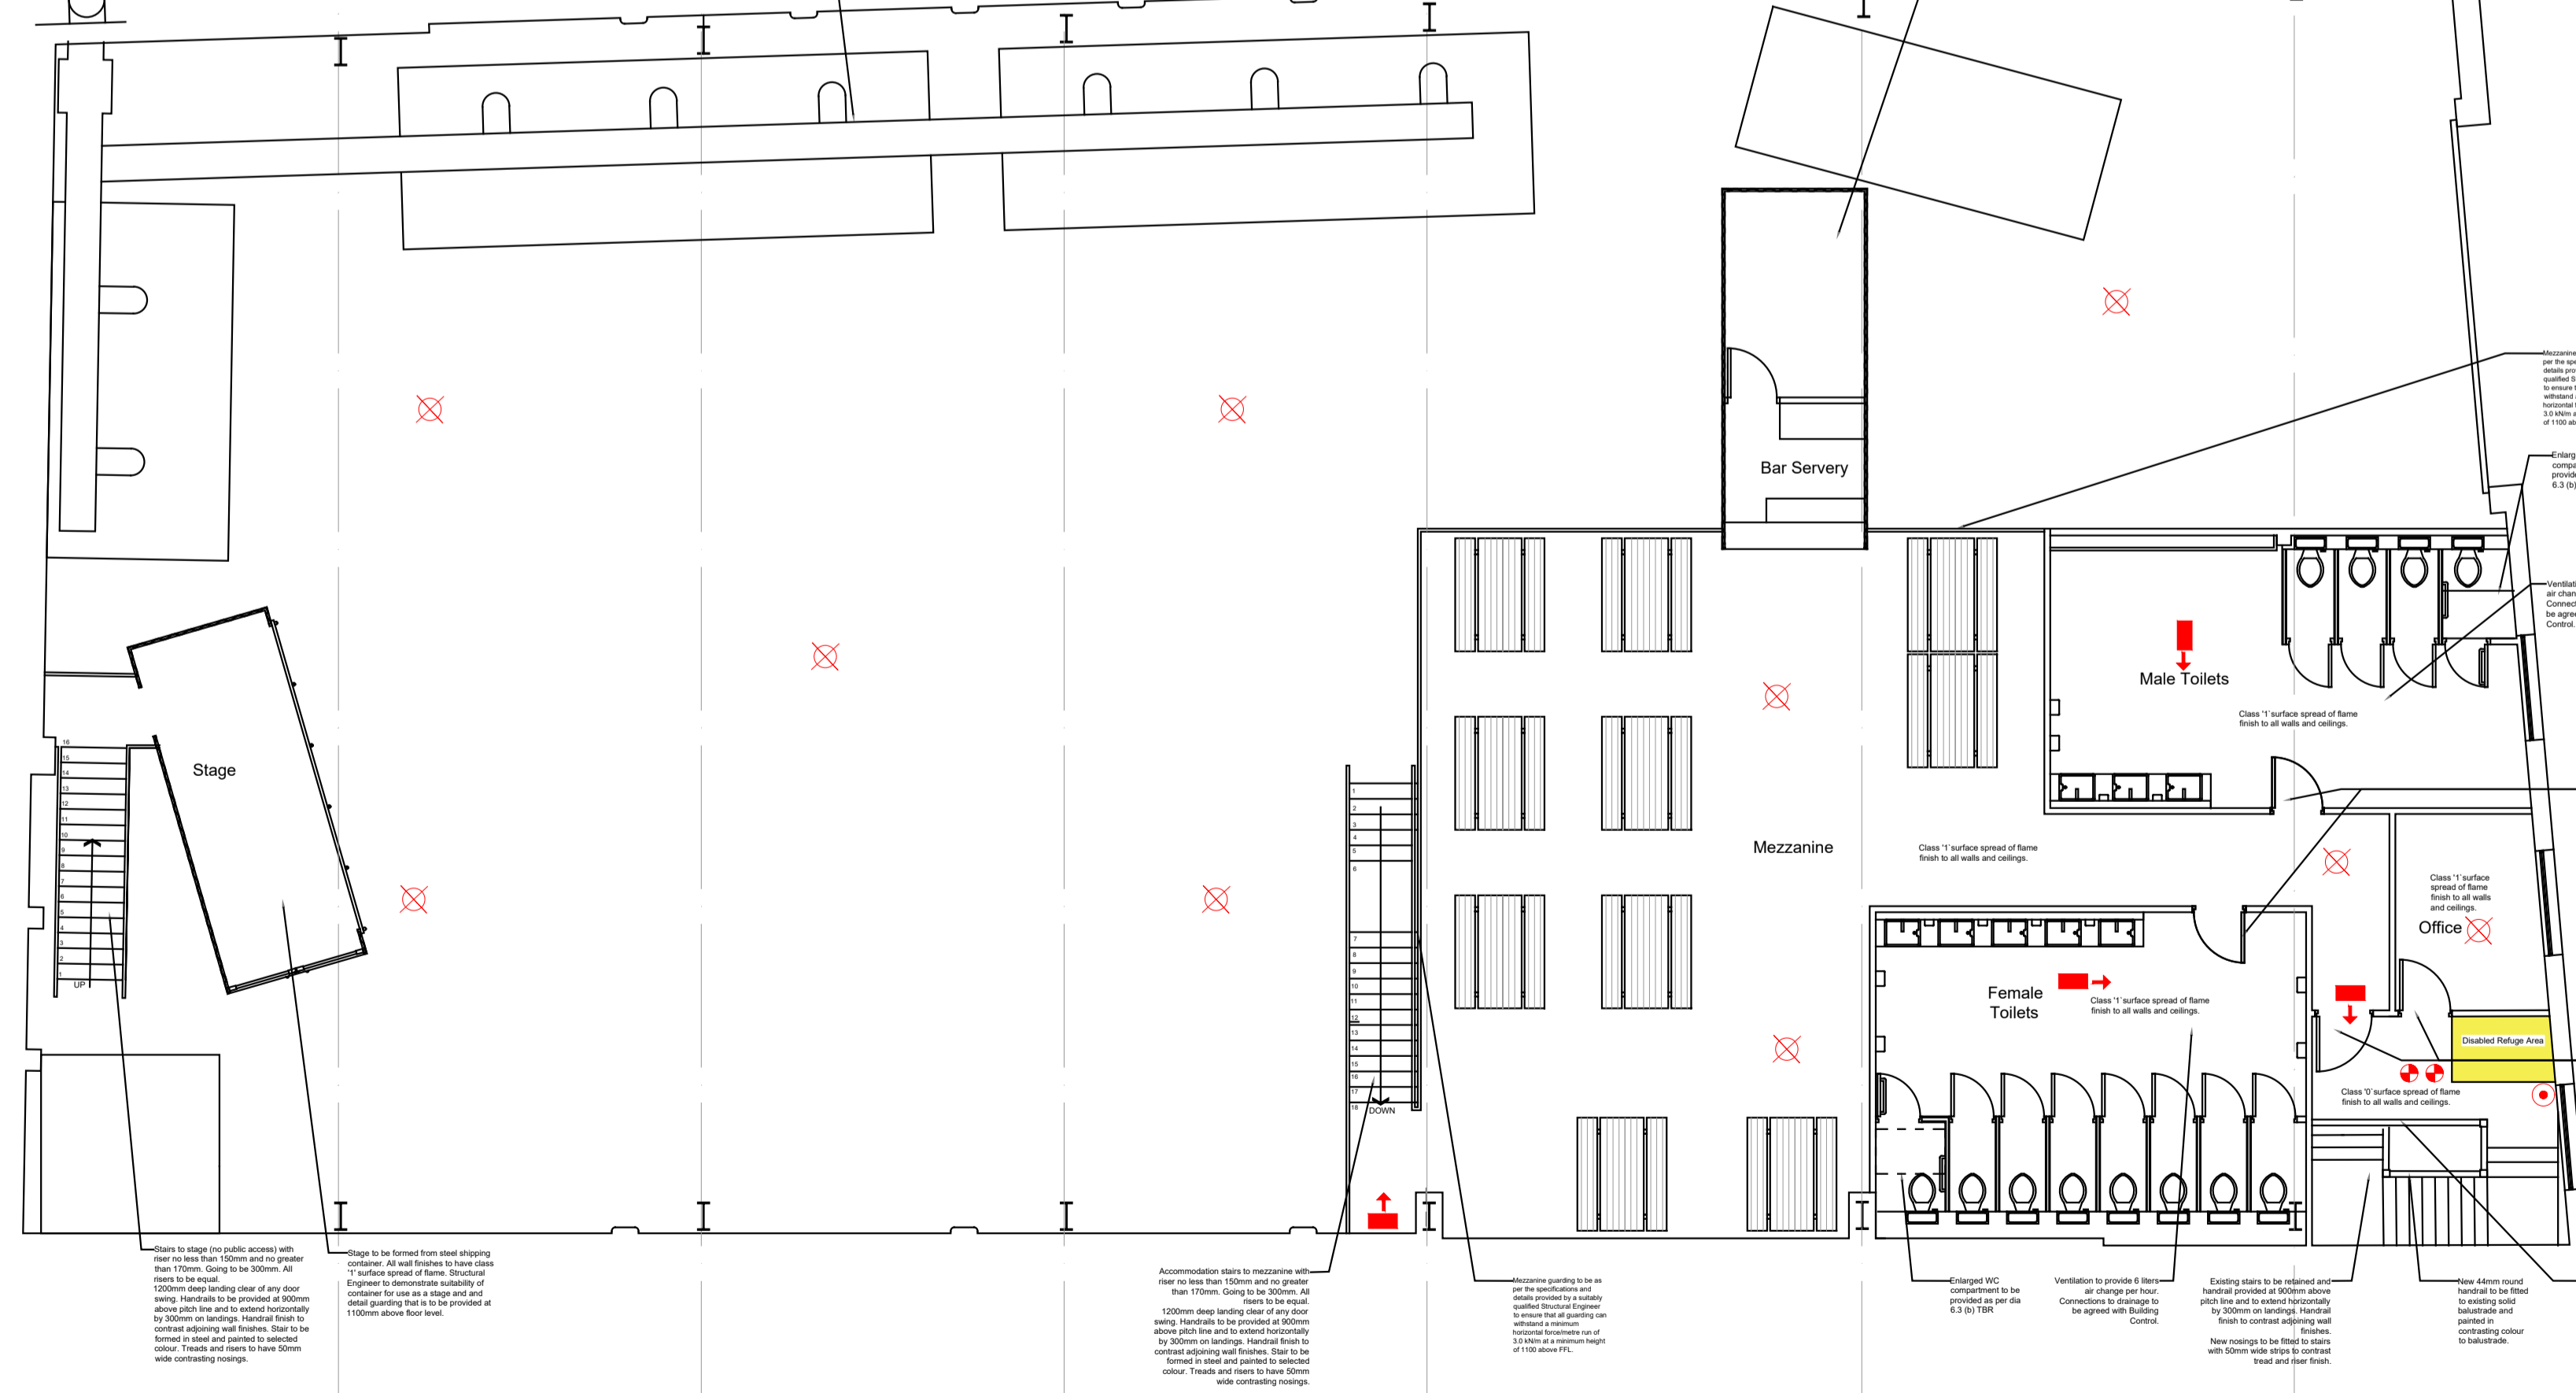

Proposed Mezzanine Floor GA Plan

Scale 1:100 @ A1 / 1:200 @ A3

Appendix 3

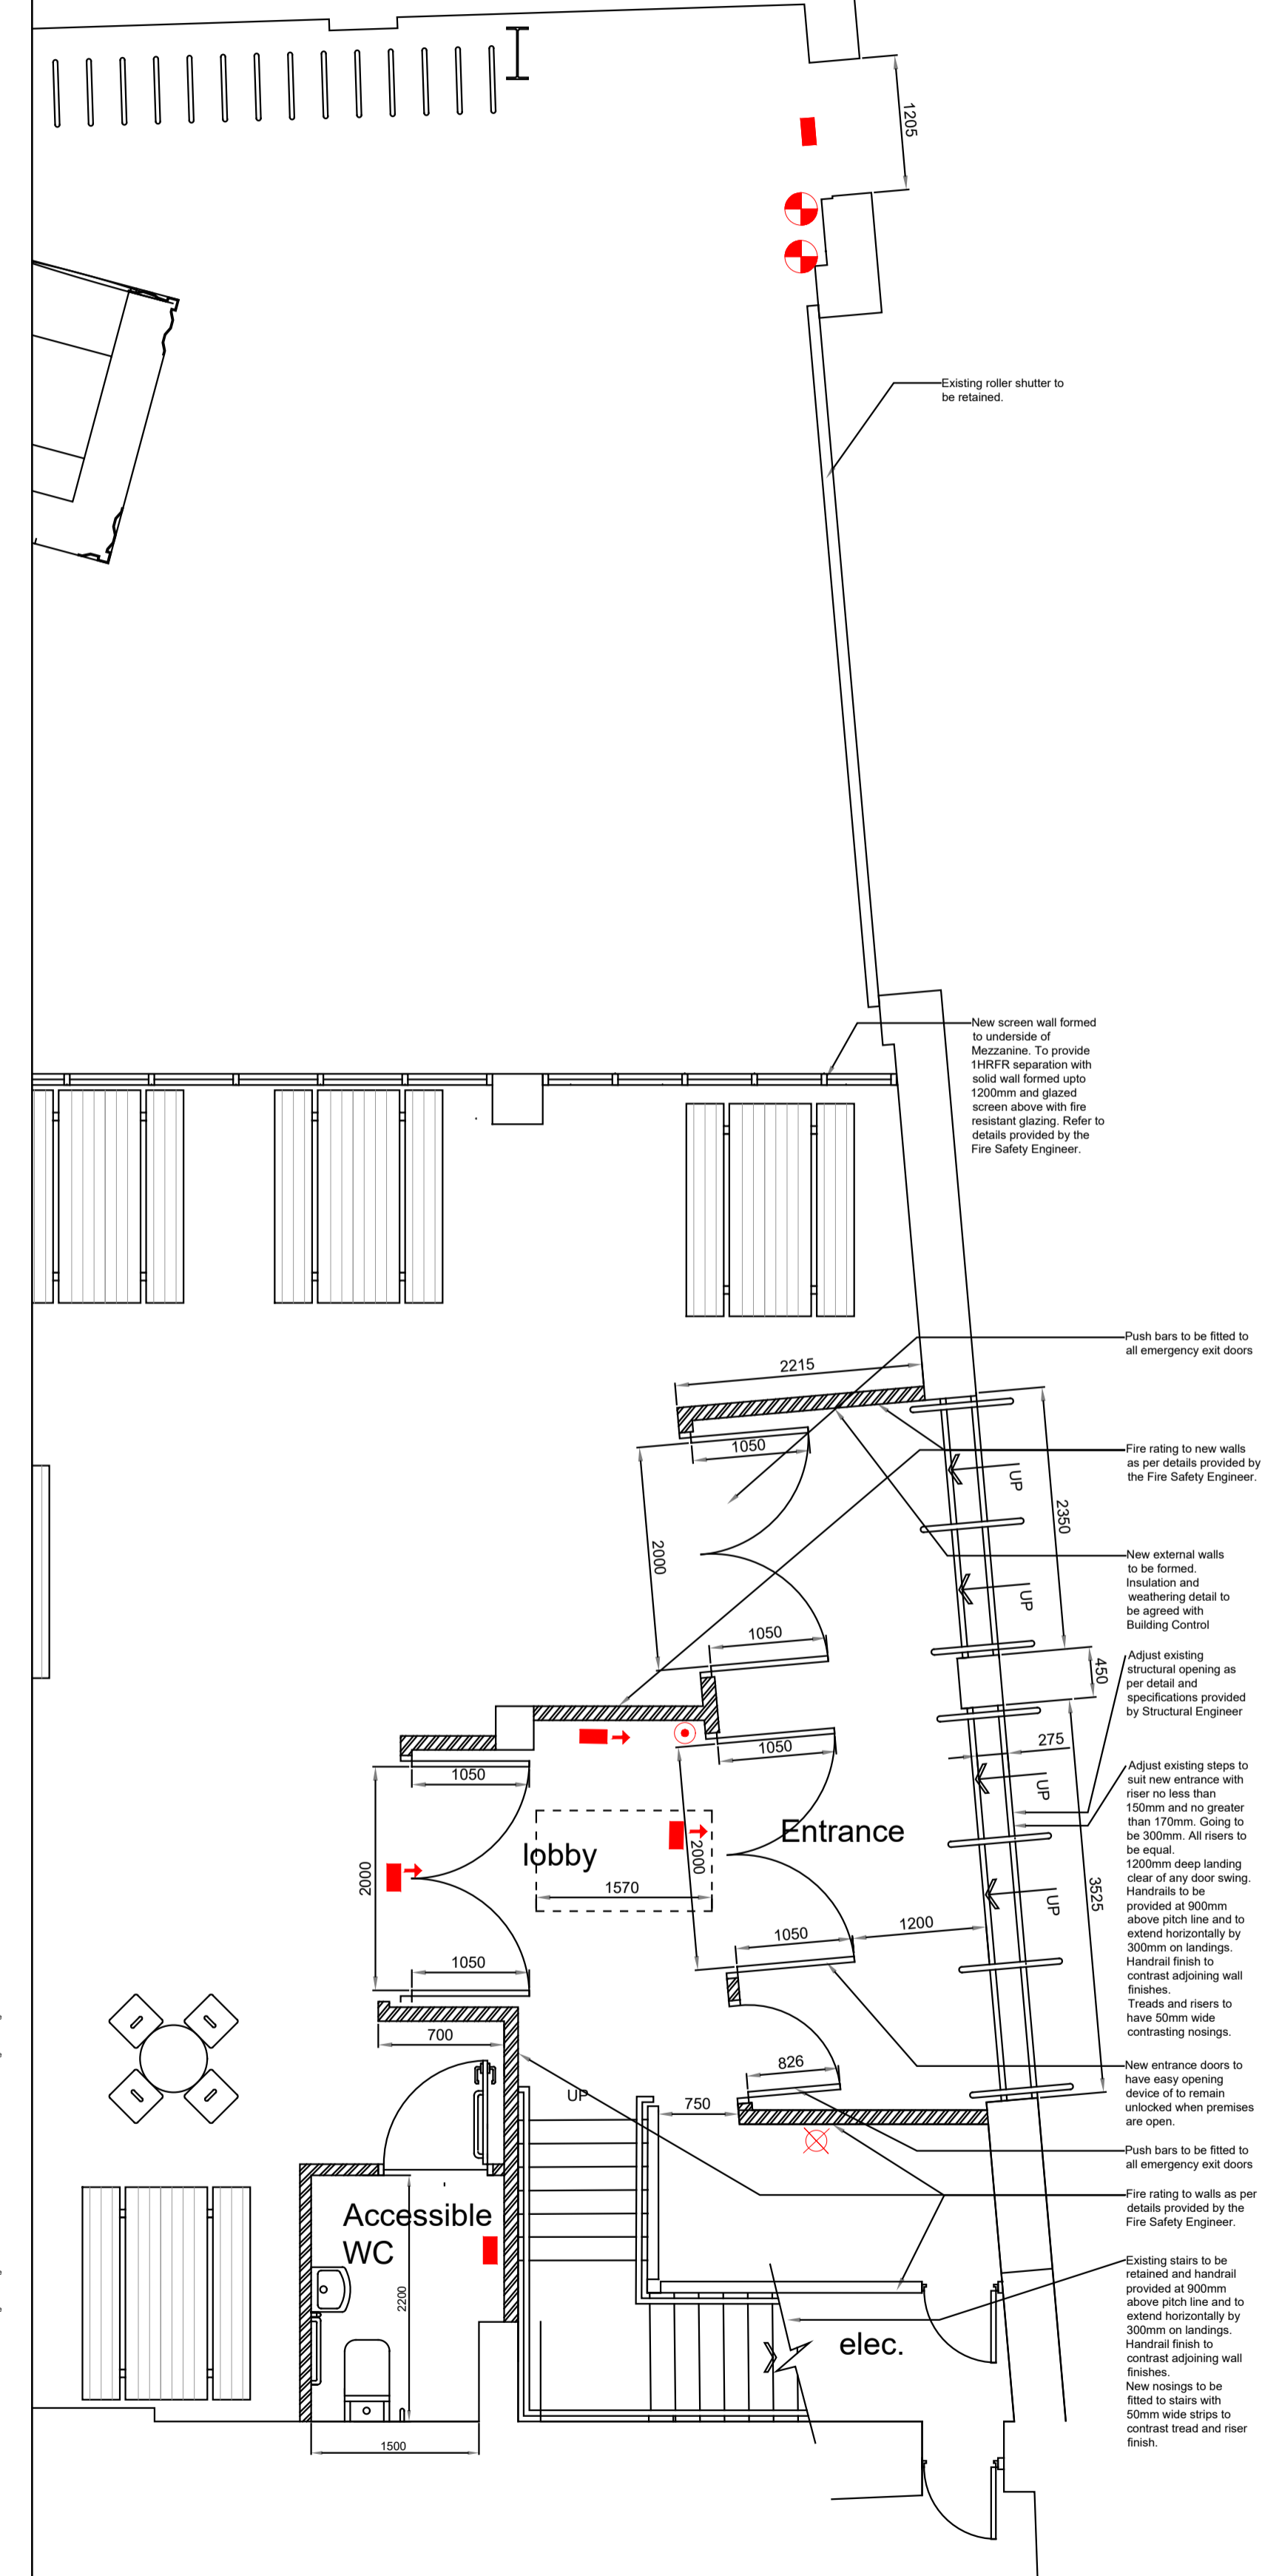

Proposed Ground Floor Entrance Detail Plan

Scale 1:50 @ A1 / 1:100 @ A3

KEY :

- FIRE EXIT SIGN
- BREAK POINT
- EMERGENCY LIGHTING
- SMOKE DETECTOR

PROJECT	Arnott's Fruit Warehouse		
ADDRESS	16 - 20 Dunbar Street, Belfast, BT1 2LH		
CLIENT	L Bannon		
DRG NO	REV	SCALE	DATE
PL-01	/	1:100@A1	July 2021
DRAWN BY	CHECKED BY		
MS	HJ		
DRG TITLE	Proposed Floor Plans - Electrical / Fire		